


PLUMBING PLAN
SCALE: 1/4" = 1'

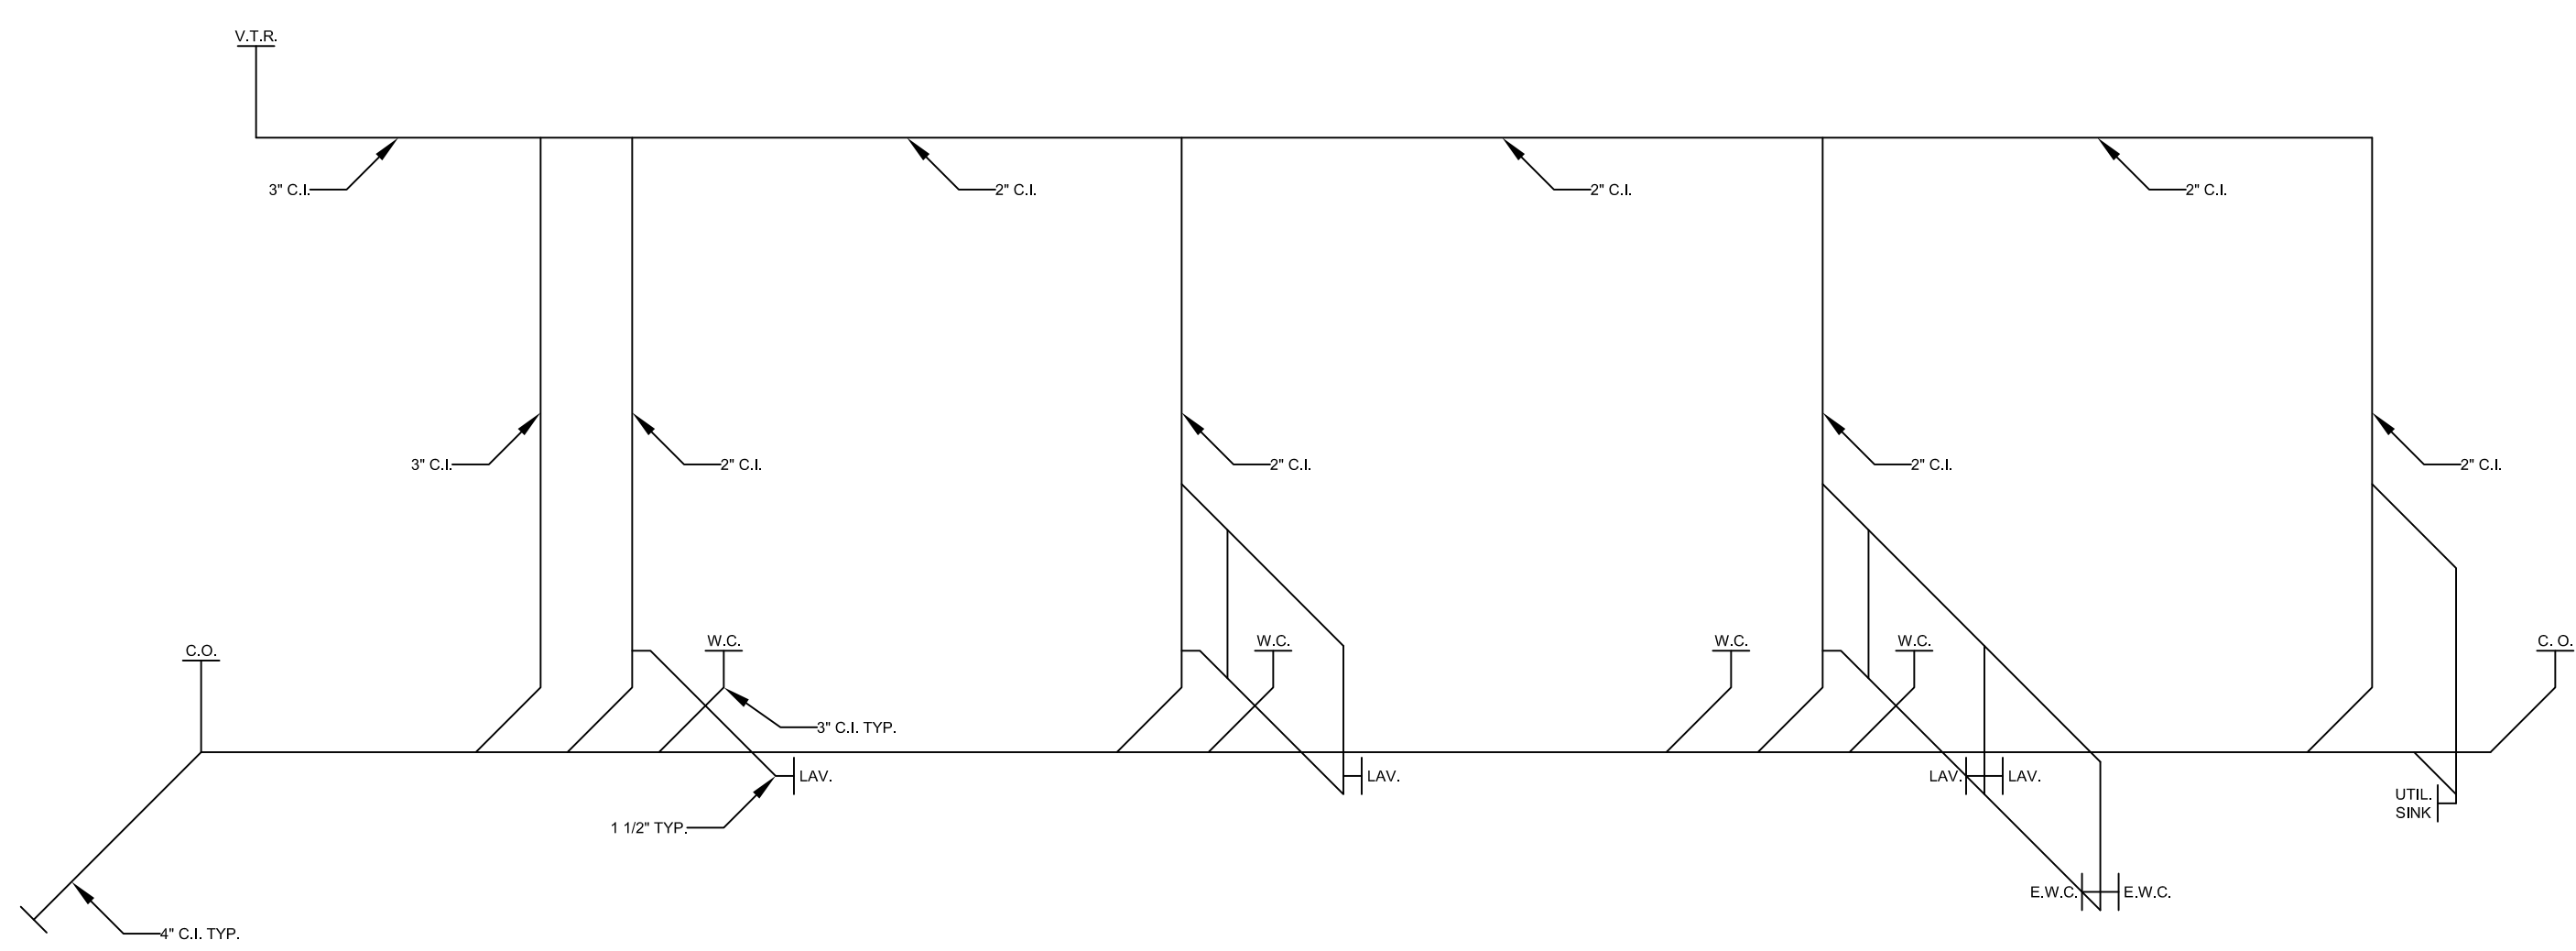

PLUMBING RISER DIAGRAM
NO SCALE

PLUMBING MATERIALS:
SEWER:
SERVICE WEIGHT CAST IRON BELOW GROUND
NO HUB CAST IRON ABOVE GROUND
SUPPLY:
COPPER TYPE "L"

NOTE:
SEE SHEET AS FOR HIC REQUIREMENTS

ERNEST J. GALLOR, PE

JJC TECHNOLOGY
16 JAMES STREET
SARATOGA SPRINGS, NY 12866
518.583.3708
john@jjctech.com

OWNER:
BDJ DEVELOPMENT
713 RIVERVIEW ROAD
REXFORD, NY 12148

**700 NEW LOUDON ROAD
LATHAM, NY 12110**

DATE	REVISIONS
05.23.03	PER BUILDING DEPT.

DRAWN BY: JJC/J
CHECKED BY: ENG
SCALE: AS NOTED
DATE: 03.11.03

**PLUMBING
PLAN**

P1